

Galgotia University

Architectural Association Pvt. Ltd.
 Plot No. 68 Sector 22,
 Gurgaon, Haryana 122001 India.
 Ph: +91 1242333333
 Fax: +91 1242333333
 Email: info@galgotia.edu

Structure: BVP Design Consultant Pvt. Ltd.
 12A, Block No. 12,
 Sector 22, Gurgaon, Haryana 122001 India.
 Ph: +91 1242333333
 Email: info@bvpdesign.com

MEP CONSULTANT:
 SNC-Group Consulting Engineers LLP
 206, 2nd Floor, Time Centre
 20, Connaught Place, New Delhi-110002
 Ph: +91 11 26111111
 Email: info@sncgroup.com

Location: ST-02, 4th Floor, Block 12, Sector 22, Gurgaon, Haryana 122001 India.

Client: **GALGOTIA UNIVERSITY**
 Sec. 22, Block 12, G.P. Area

Project Title: **GALGOTIA UNIVERSITY ENG. ADMIN**

Drawing Title: **FOURTH FLOOR HVAC LAYOUT**

Drawn by: **MEP**


Checked by: **MEP**

Scale: 1:100

Date: 25.01.24

Revision: R1

- revision**
- | NO | DATE | BY | REASON |
|----|----------|-------|--------|
| 01 | 25/01/24 | G.F.C | ISSUE |

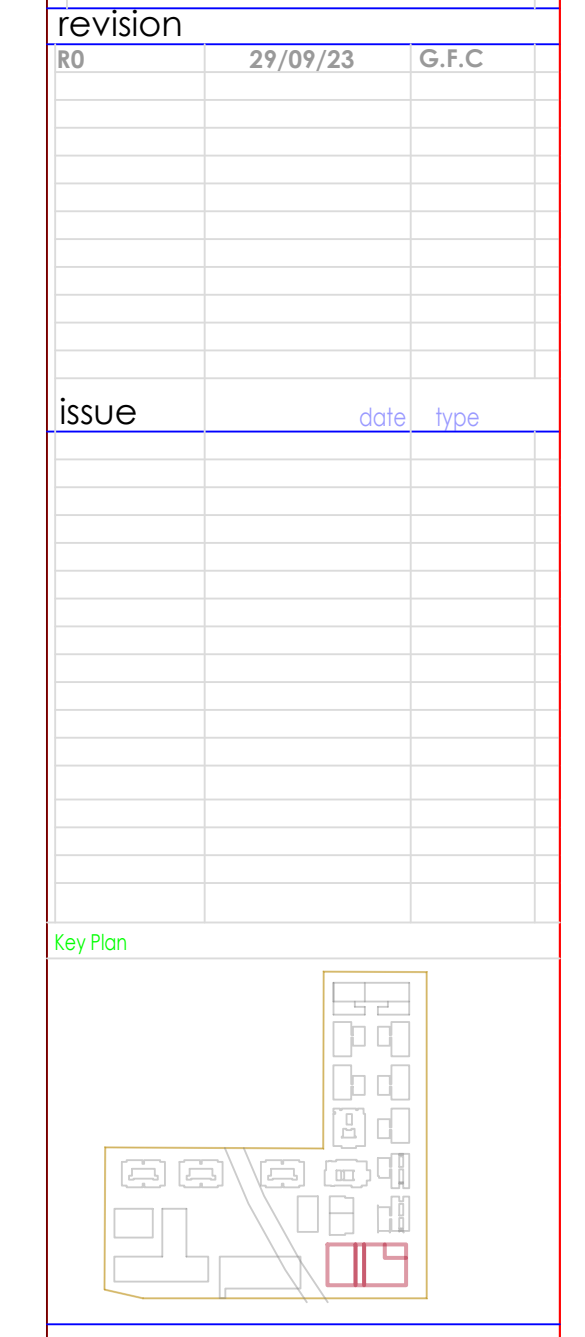

Galgotia University

Architectural Association Pvt. Ltd.
 Plot No. 68 Sector 22,
 Gurgaon, Haryana 122001 India.
 Ph: +91 1242333333
 Fax: +91 1242333333
 Email: info@galgotia.edu

Structure: BVP Design Consultant Pvt. Ltd.
 12A, Block No. 12,
 Sector 22, Gurgaon, Haryana 122001 India.
 Ph: +91 1242333333
 Email: info@bvpdesign.com

MEP CONSULTANT:
 SNC-Group Consulting Engineers LLP
 206, 2nd Floor, Time Centre
 20, Connaught Place, New Delhi-110002
 Ph: +91 11 26111111
 Email: info@sncgroup.com

Location: ST-02, 4th Floor, Block 12, Sector 22, Gurgaon, Haryana 122001 India.

Client: **GALGOTIA UNIVERSITY**
 Sec. 22, Block 12, G.P. Area

Project Title: **GALGOTIA UNIVERSITY ENG. ADMIN**

Drawing Title: **FOURTH FLOOR HVAC LAYOUT**

Drawn by: **MEP**

Checked by: **MEP**

Scale: 1:100

Date: 25.01.24

Revision: R1